
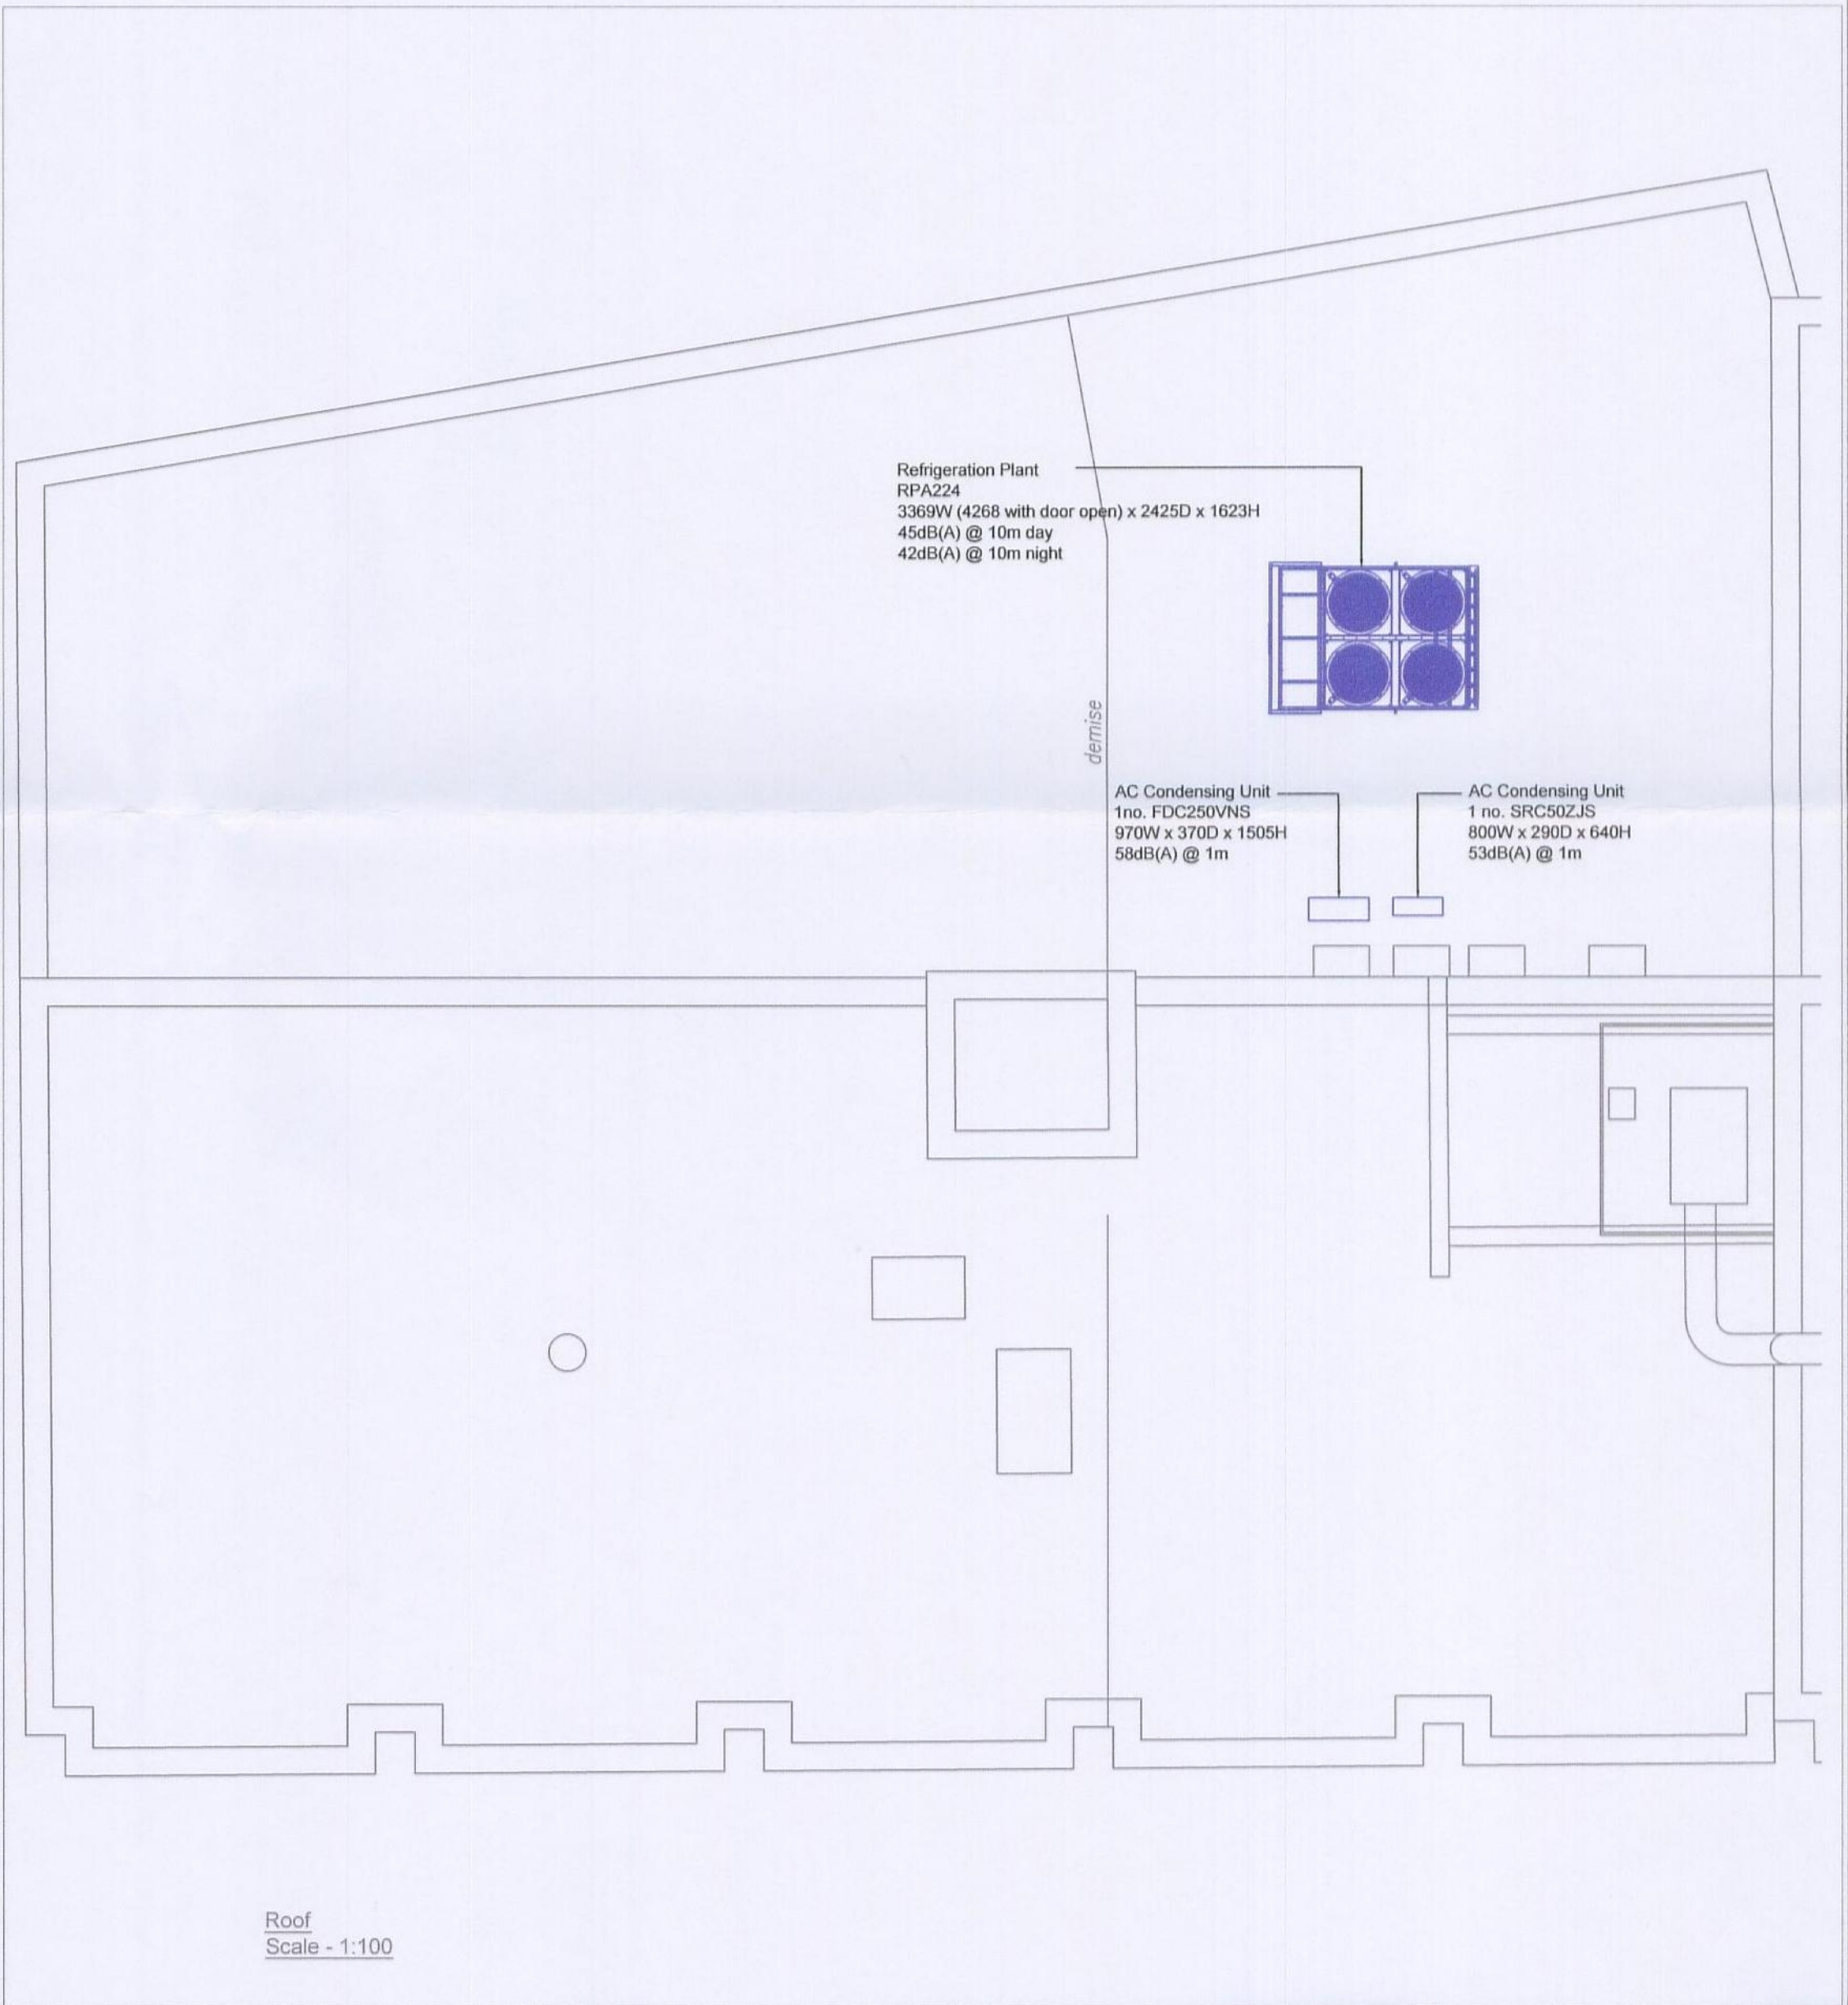


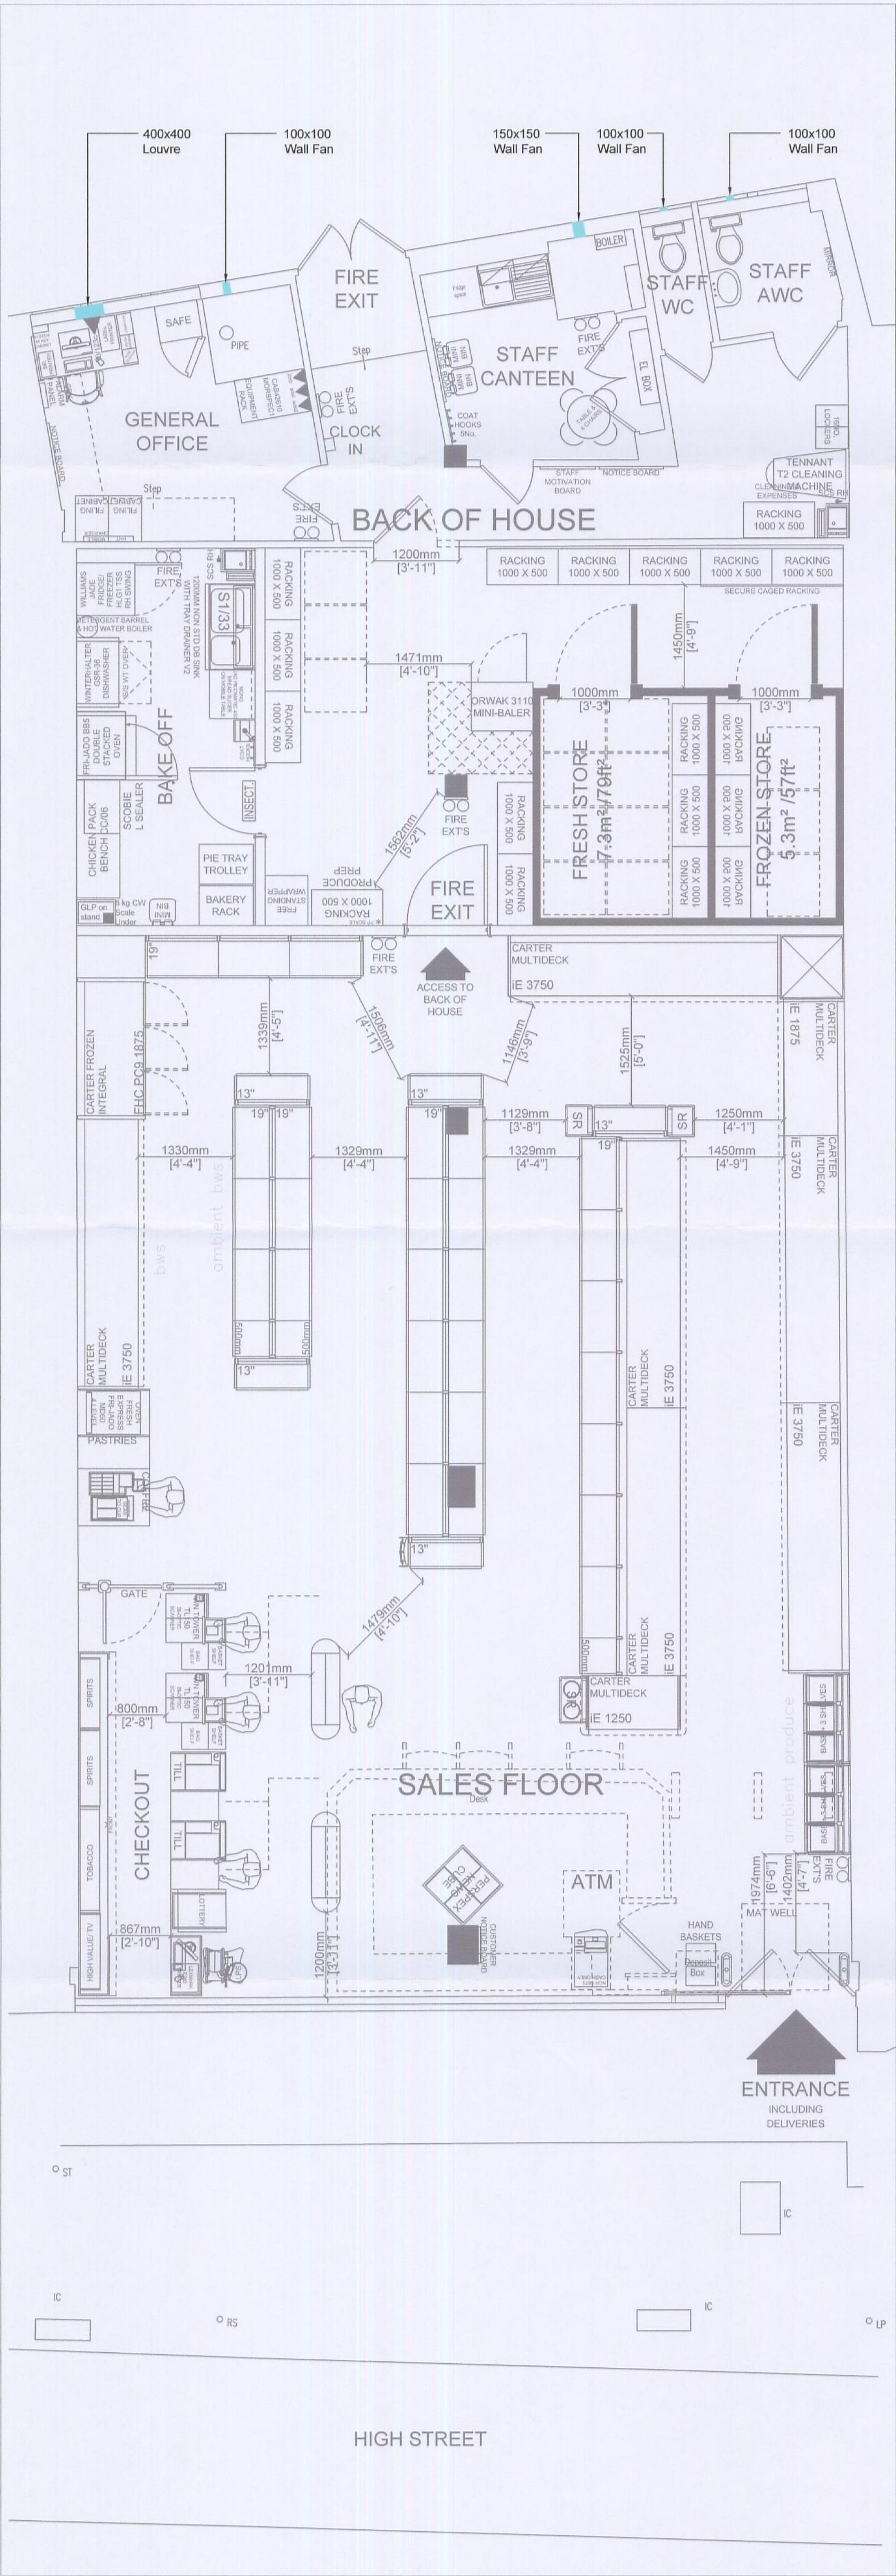

RECEIVED  
17 05 2013  
Support Services

|     |             |    |      |          |
|-----|-------------|----|------|----------|
| -   | Preliminary | MP | AC   | 17.05.13 |
| Rev | Details     | Dm | Ch'k | Date     |

## Preliminary

Status of drawing:

Space Engineering Services Ltd  
Head Office  
Causeway Central Pioneer Park Bristol BS4 3QB  
[t] 0845 602 0670 [f] 0845 602 0671  
space-engineering.co.uk

Project: **Proposed convenience unit**

Contract No: **PQ 13 12723**

Drawing Title:  
**EXTERNAL REFRIGERATION &  
MECHANICAL PLANT LAYOUT**

|           |            |          |            |
|-----------|------------|----------|------------|
| Drawn By: | Date:      | Checked: | Scale @ A1 |
| PL        | 15.05.2013 | AC       | 1:50       |
| Drg No:   | PL-01      | Rev:     | -          |