


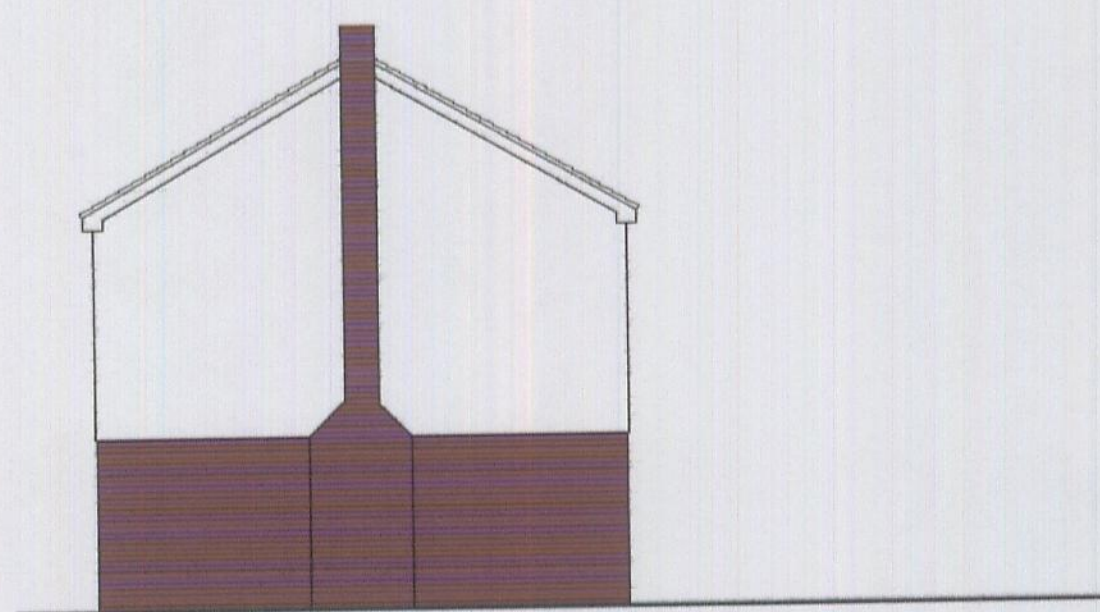


SIDE ELEVATION



REAR ELEVATION
EXISTING ELEVATIONS
Scale 1:100



SIDE ELEVATION

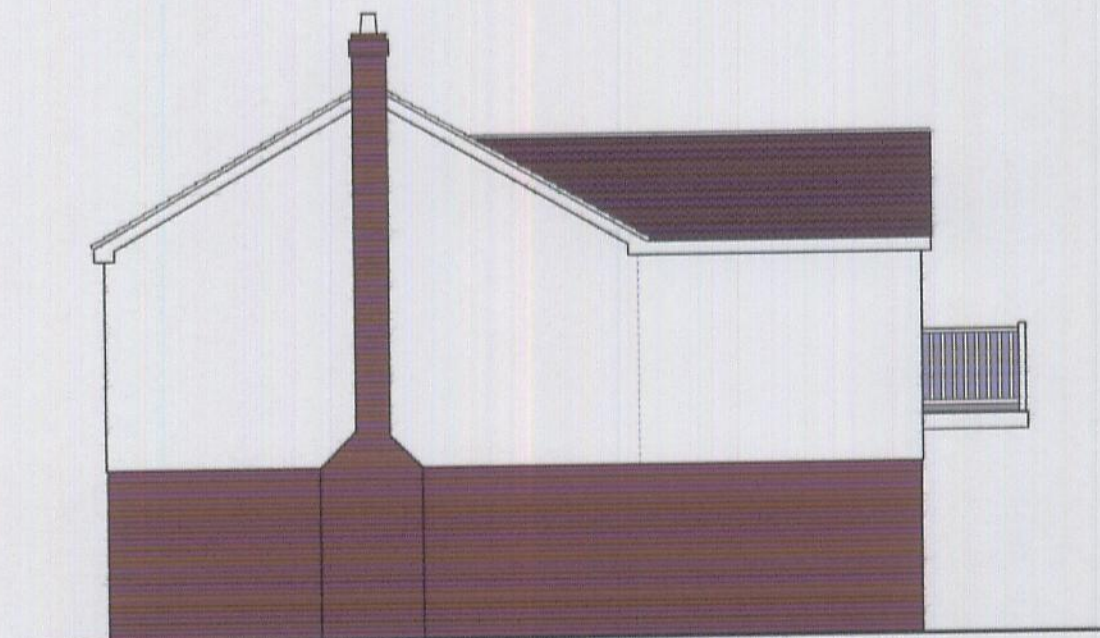


SIDE ELEVATION




REAR ELEVATION
PROPOSED ELEVATIONS
Scale 1:100




SIDE ELEVATION

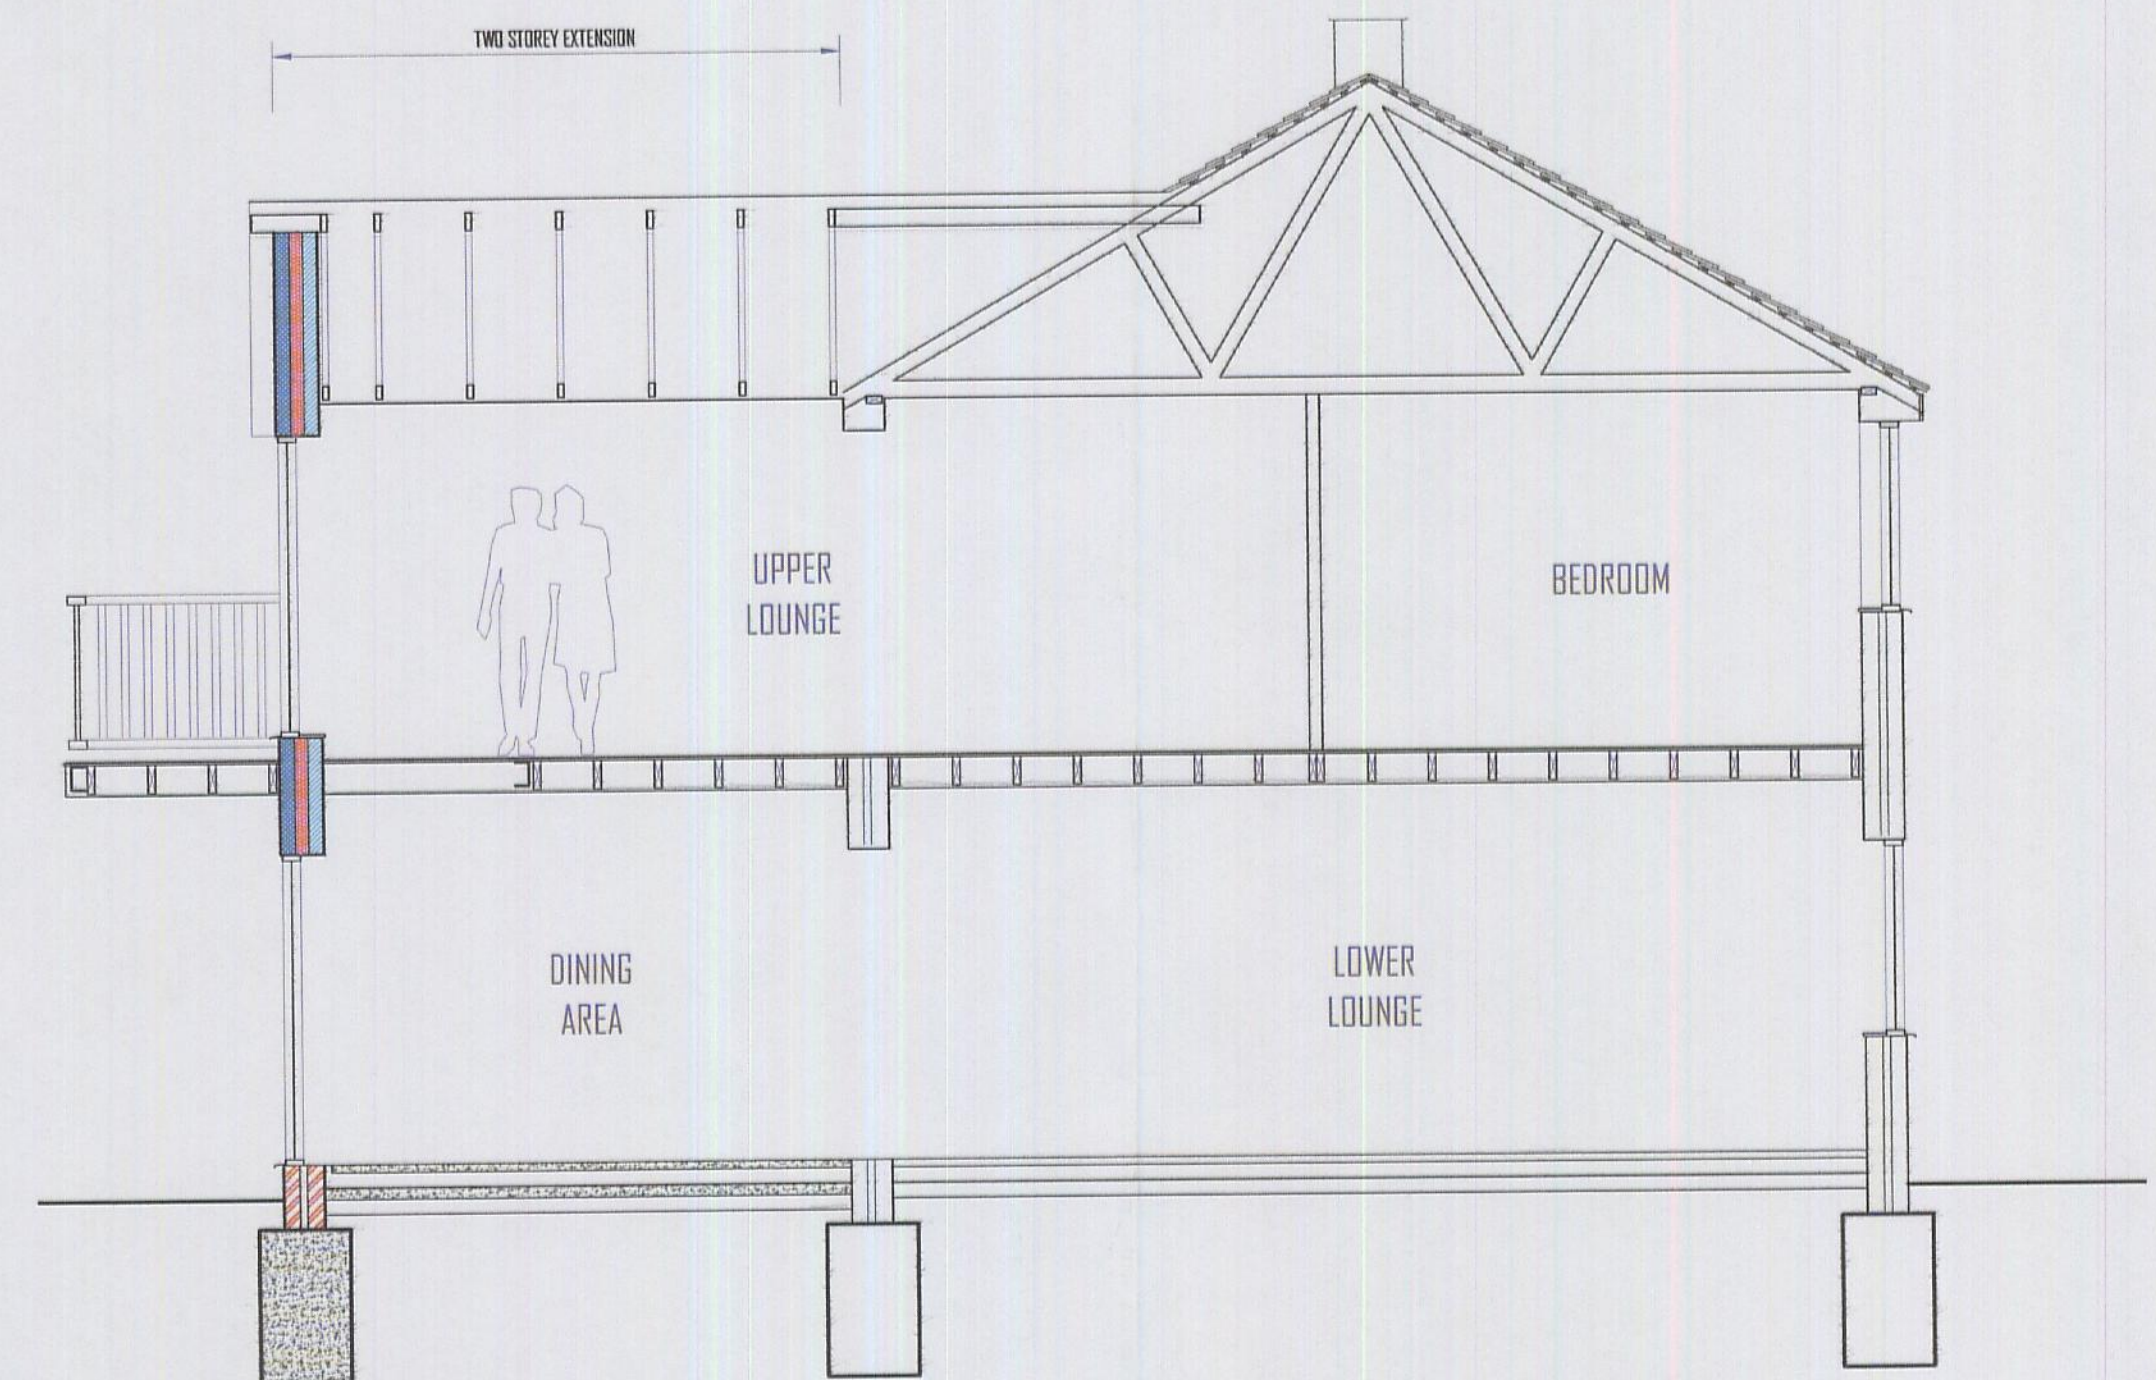


SECTION Scale 1:50

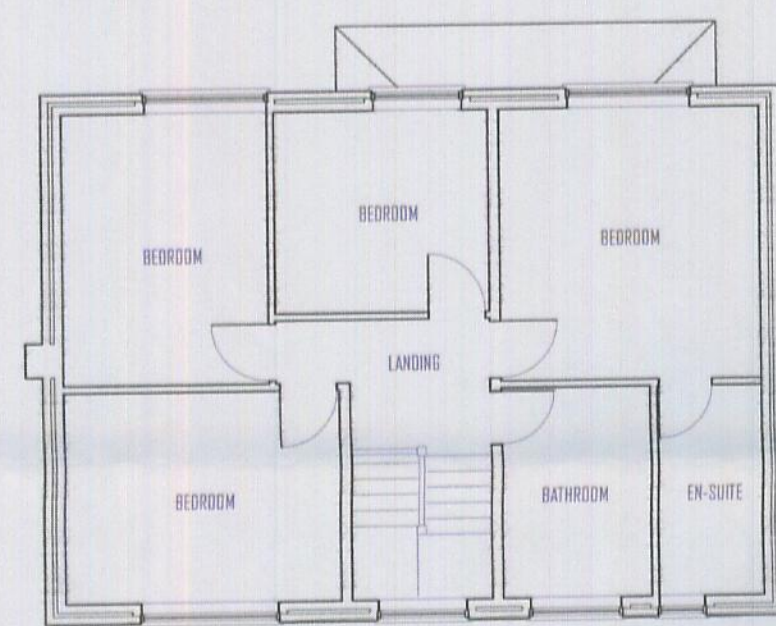


EXISTING FIRST FLOOR PLAN Scale 1:100

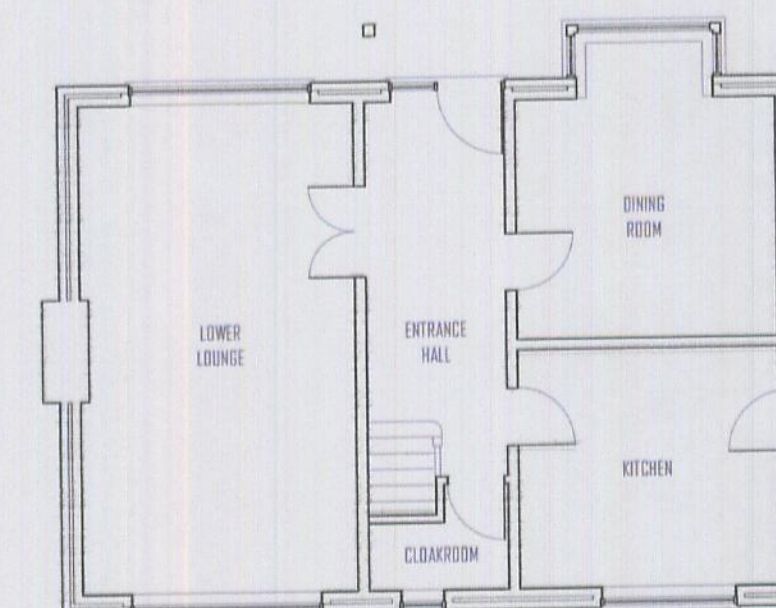

EXISTING GROUND FLOOR PLAN Scale 1:100

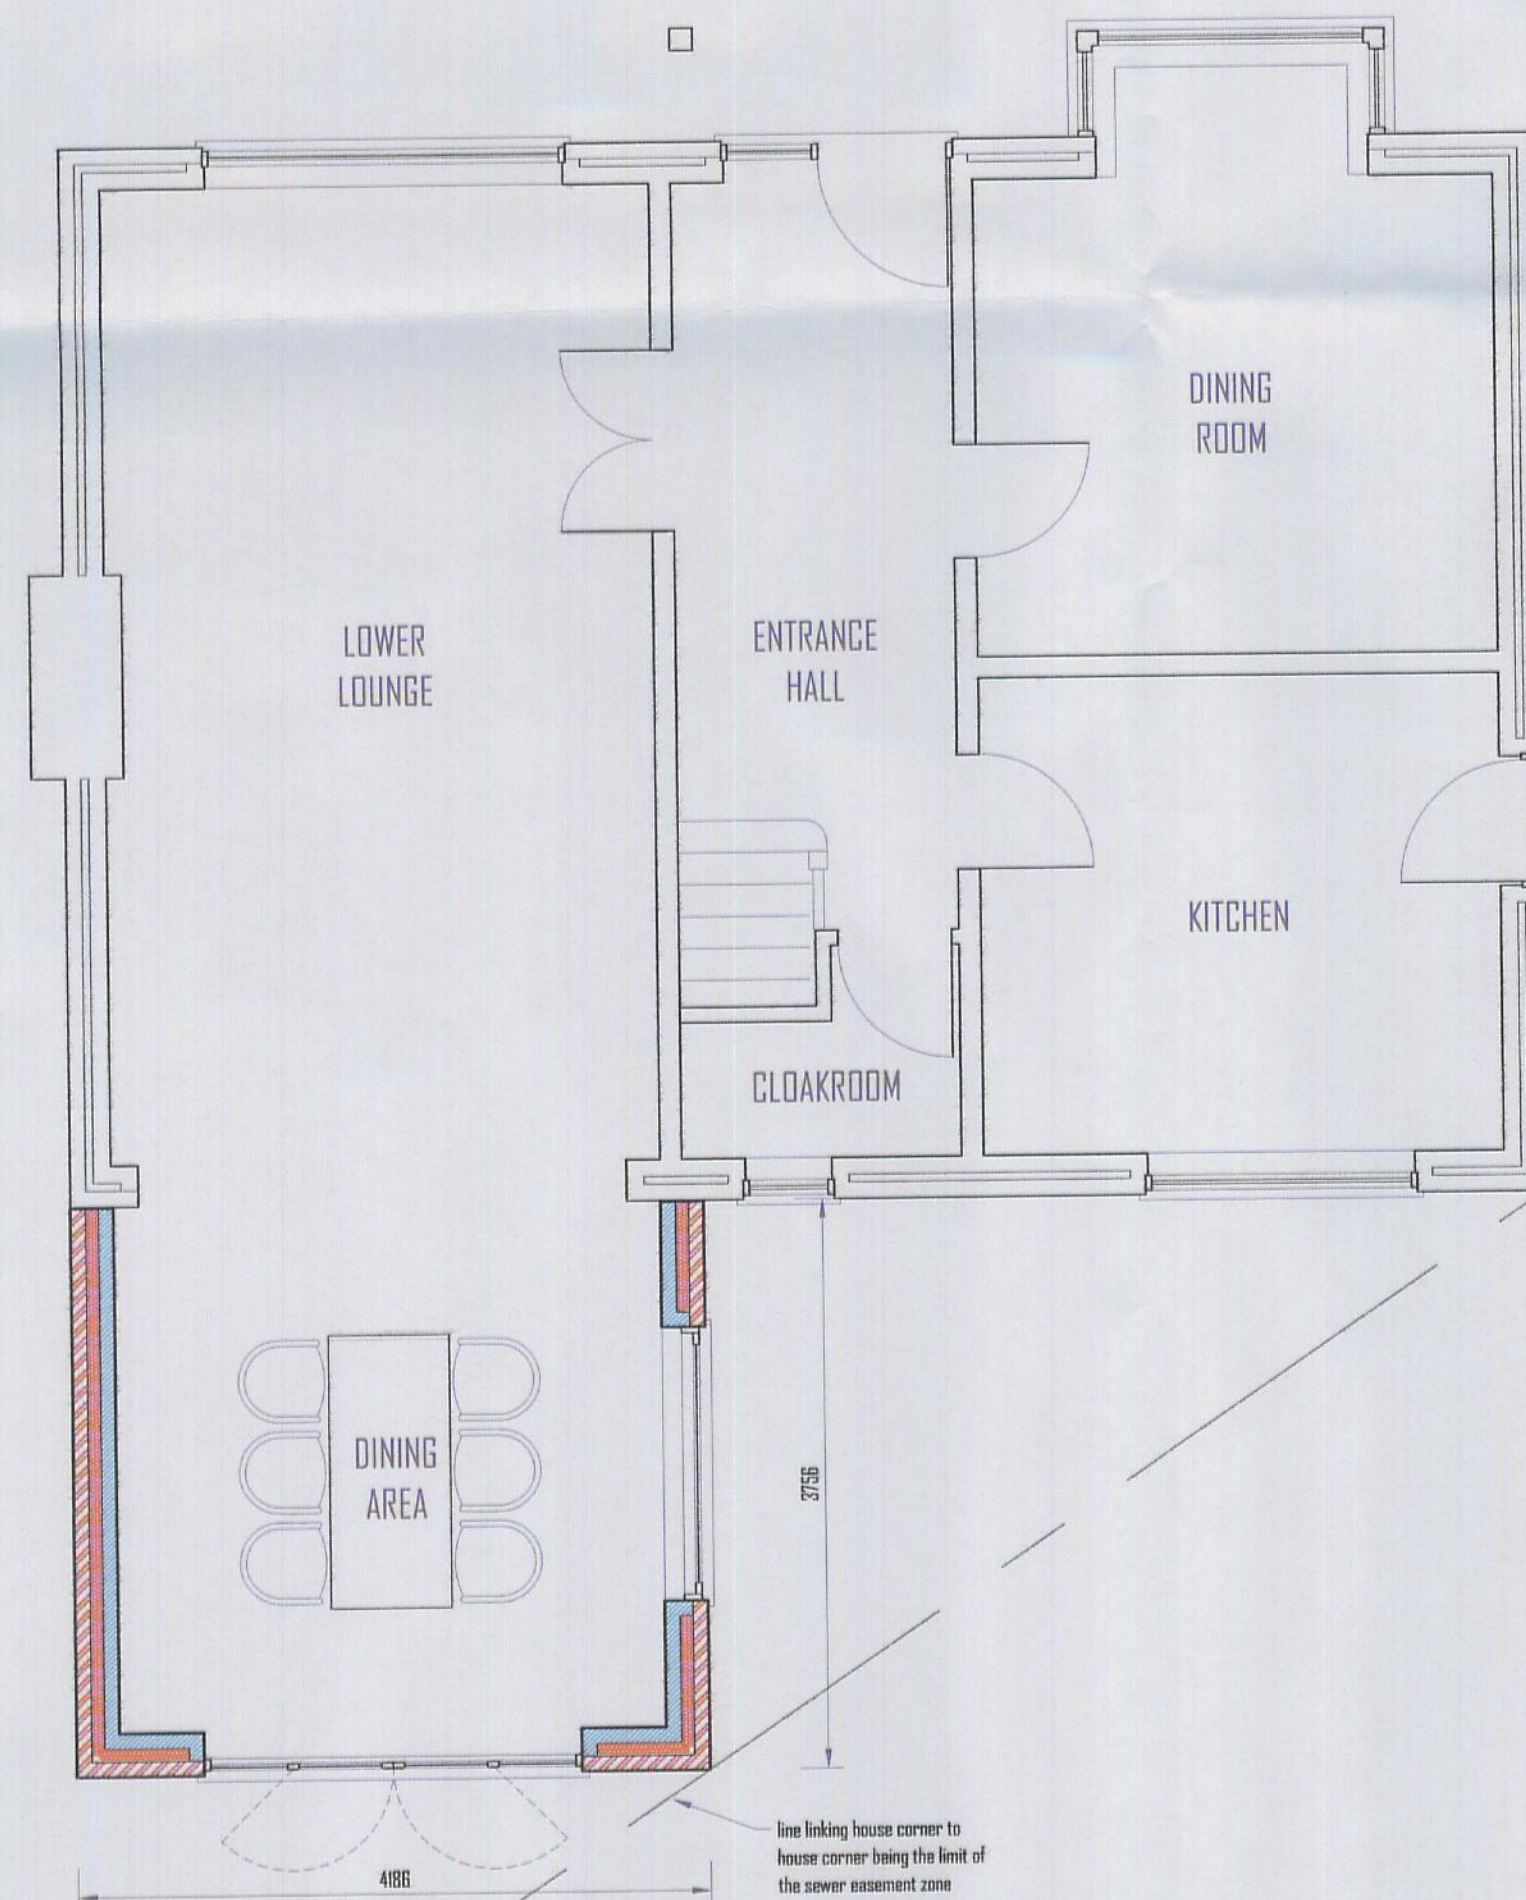

PROPOSED GROUND FLOOR PLAN Scale 1:50

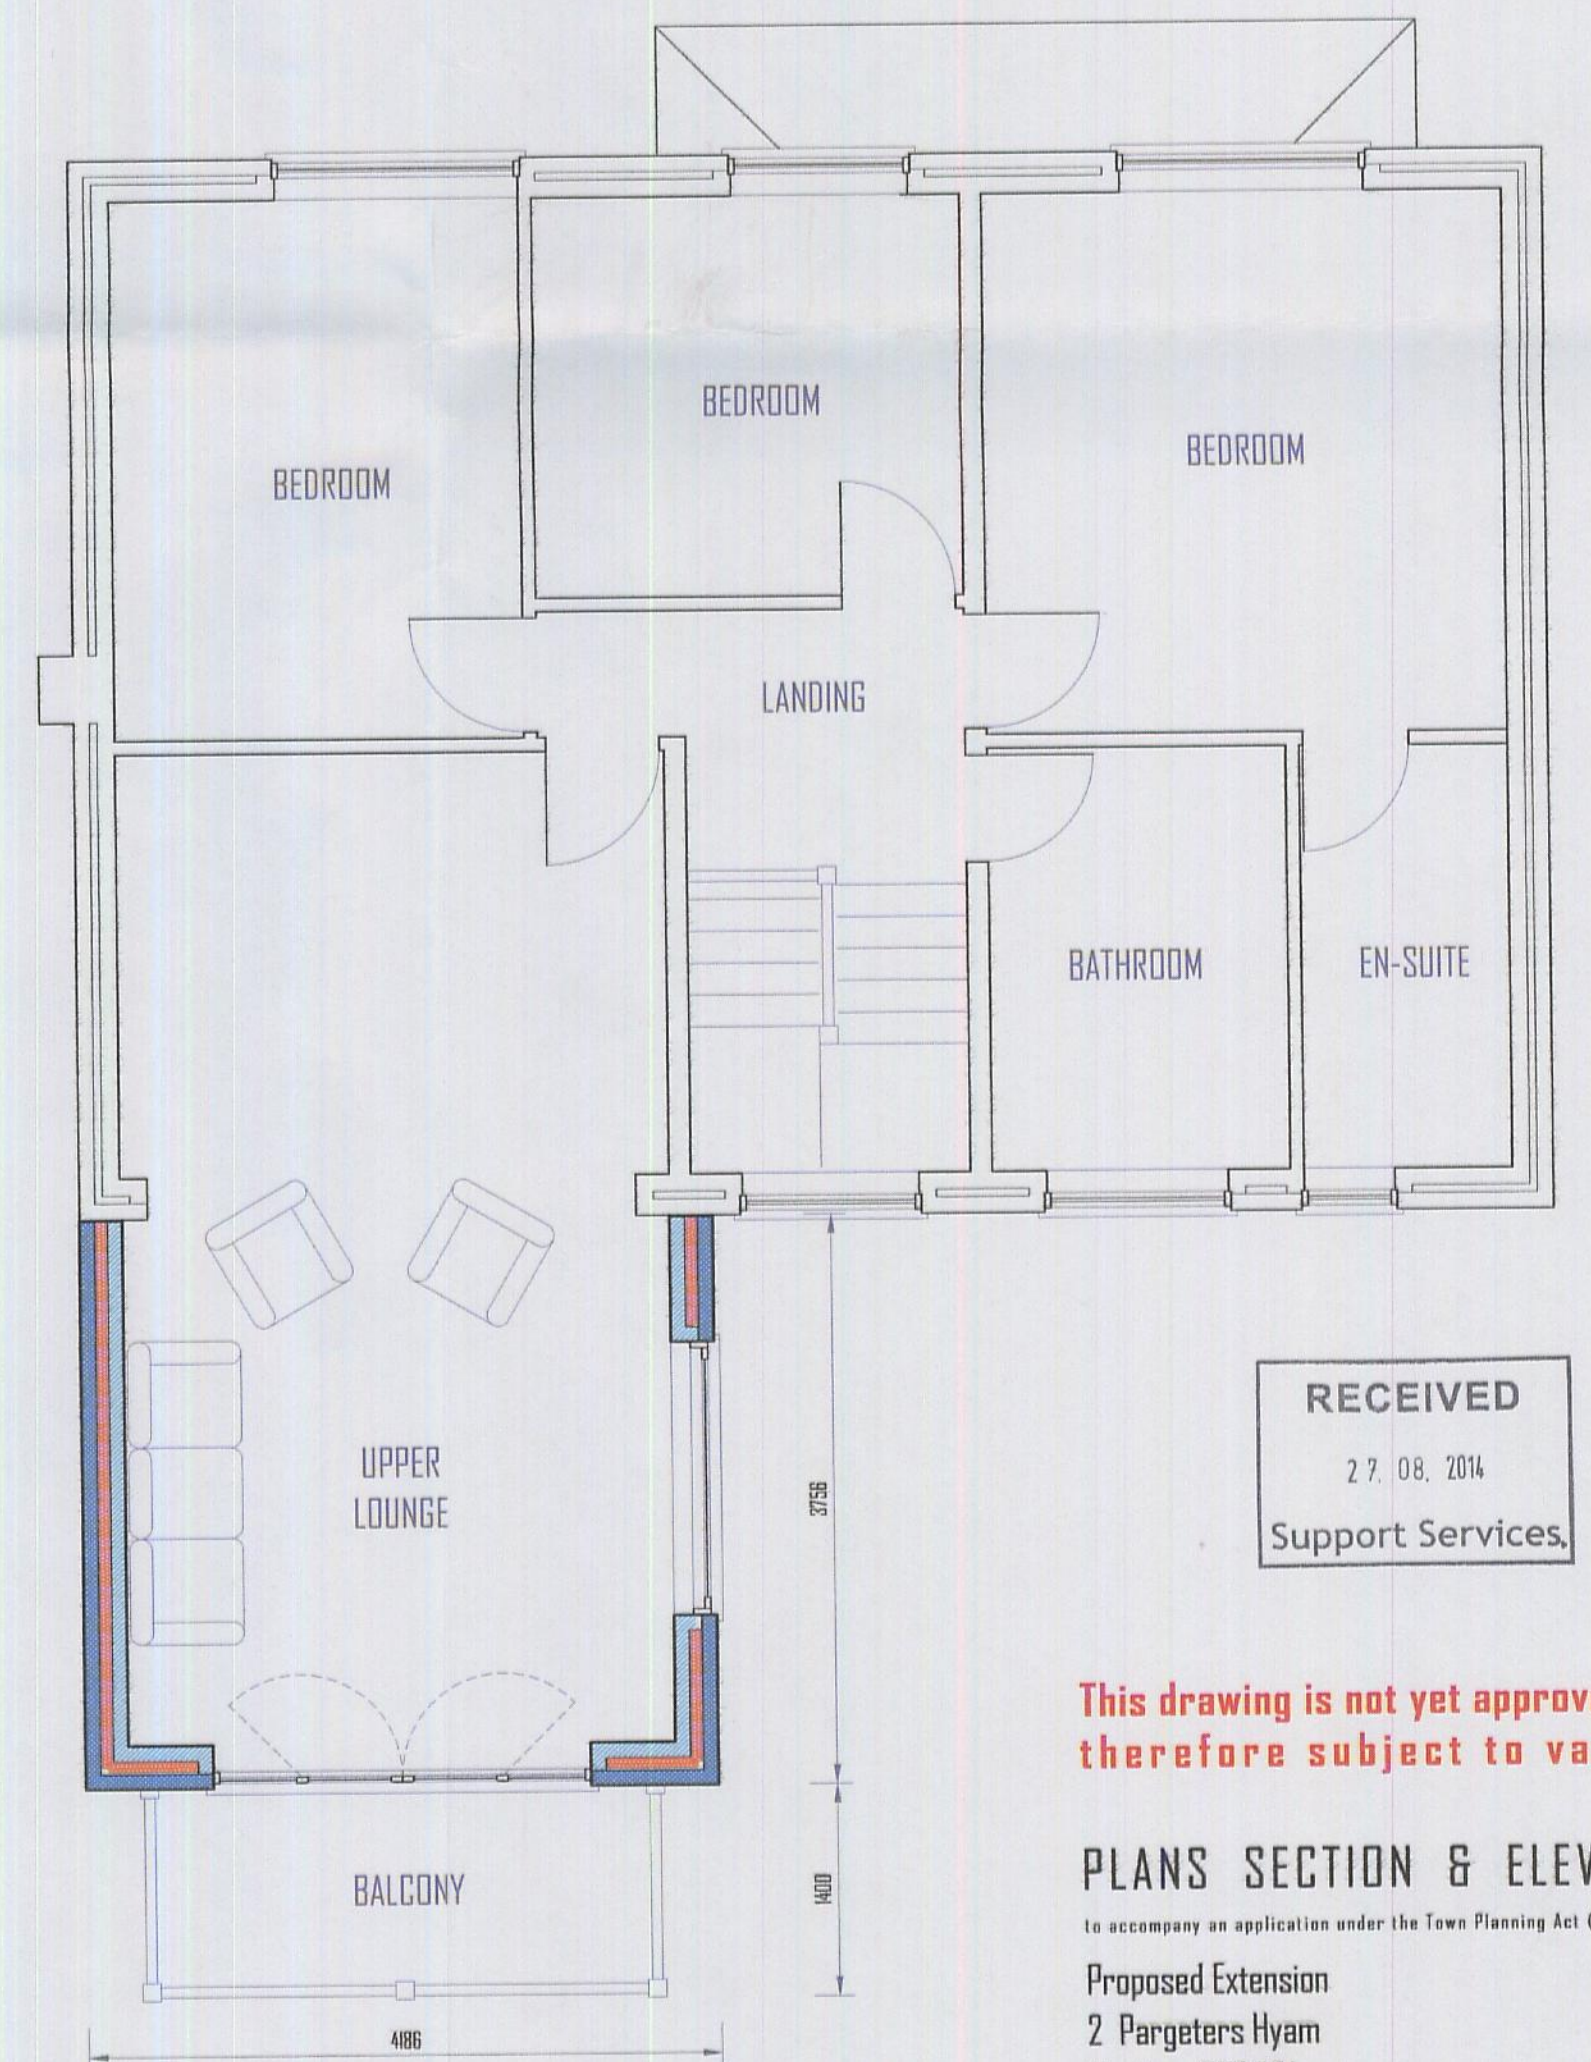

PROPOSED FIRST FLOOR PLAN Scale 1:50

RECEIVED
27.08.2014
Support Services.

This drawing is not yet approved and is therefore subject to variation

PLANS SECTION & ELEVATIONS

to accompany an application under the Town Planning Act (Full Householder)

Proposed Extension
2 Pageters Hyam
Hockley SS5 4EA

2756 03 MARK HIPSEY
92 London Road
Southend on Sea
Essex SSI 1PG

All dimensions must be checked prior to commencement of fabrication. All lines of contact are assumed and are to be checked prior to commencement. Foundation design is based on assumed soil conditions and subject to assessment upon excavation. This drawing is to be read in conjunction with any specialists' drawings. This drawing serves only the purpose for which it is produced.

Mark Hipsey
Architectural Designs

2 Pageters Hyam