



SOUTH ELEVATION

EAST ELEVATION
EXISTING ELEVATIONS
Scale 1:100


NORTH ELEVATION



SOUTH ELEVATION

EAST ELEVATION
PROPOSED ELEVATIONS
Scale 1:100

NORTH ELEVATION

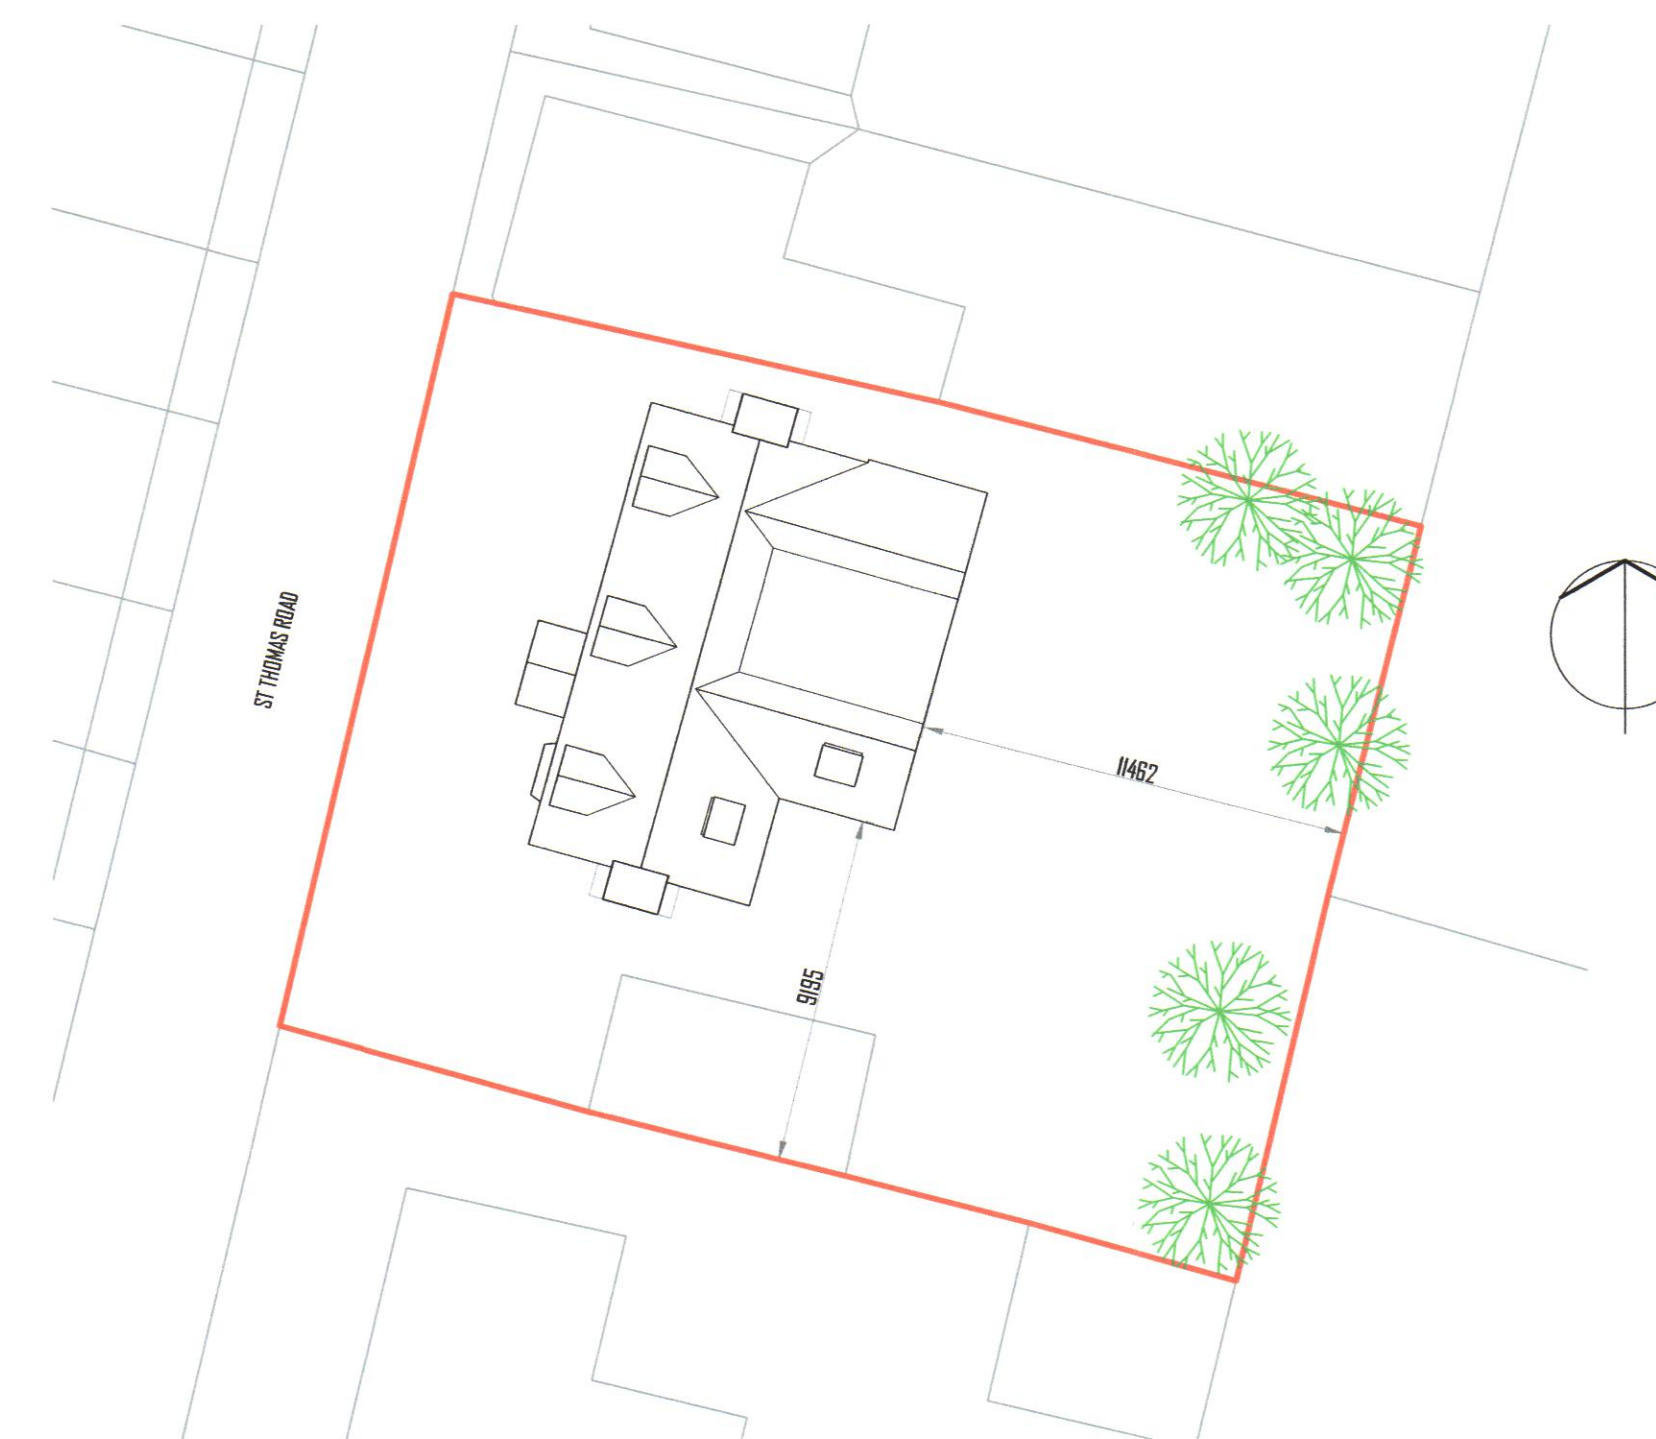

SITE & ROOF PLAN Scale 1:200


therefore subject to variation






LOCATION PLAN Scale 1:1250




BLOCK PLAN Scale 1:500

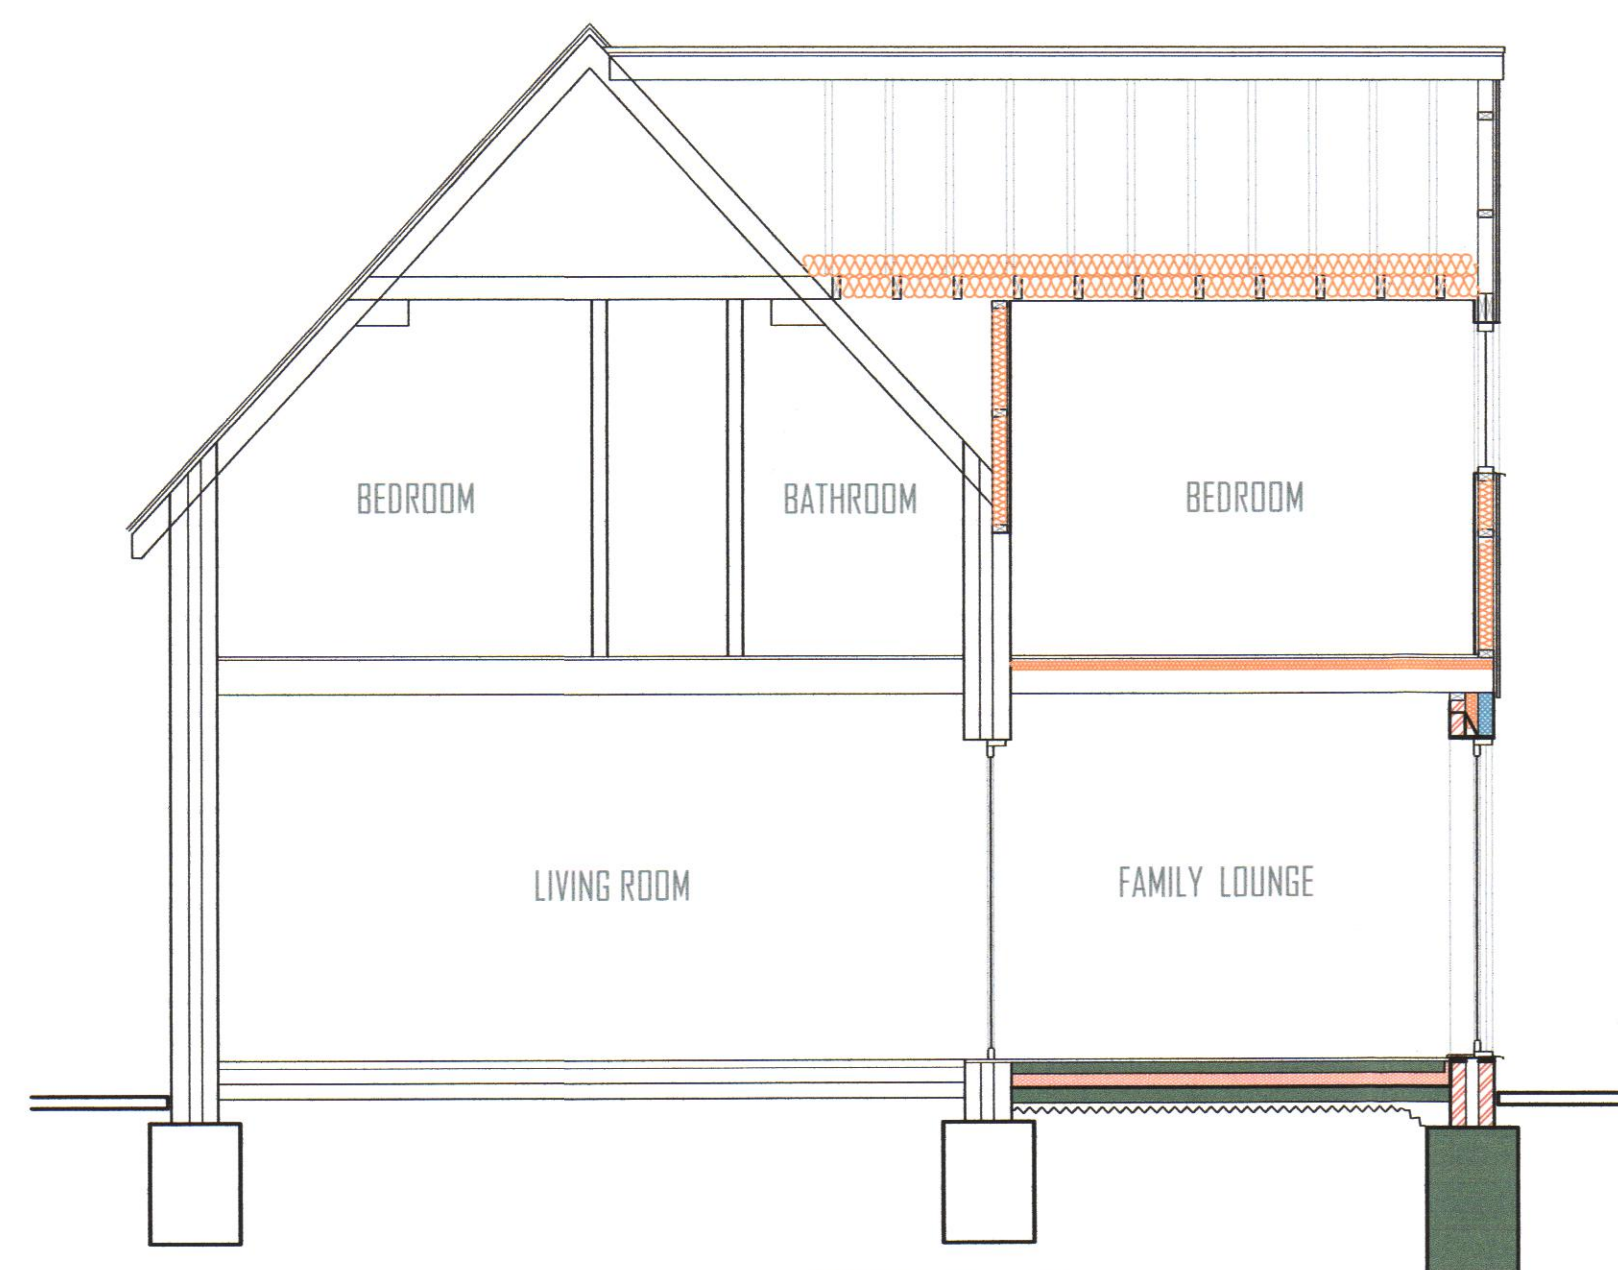

SECTION Scale 1:50

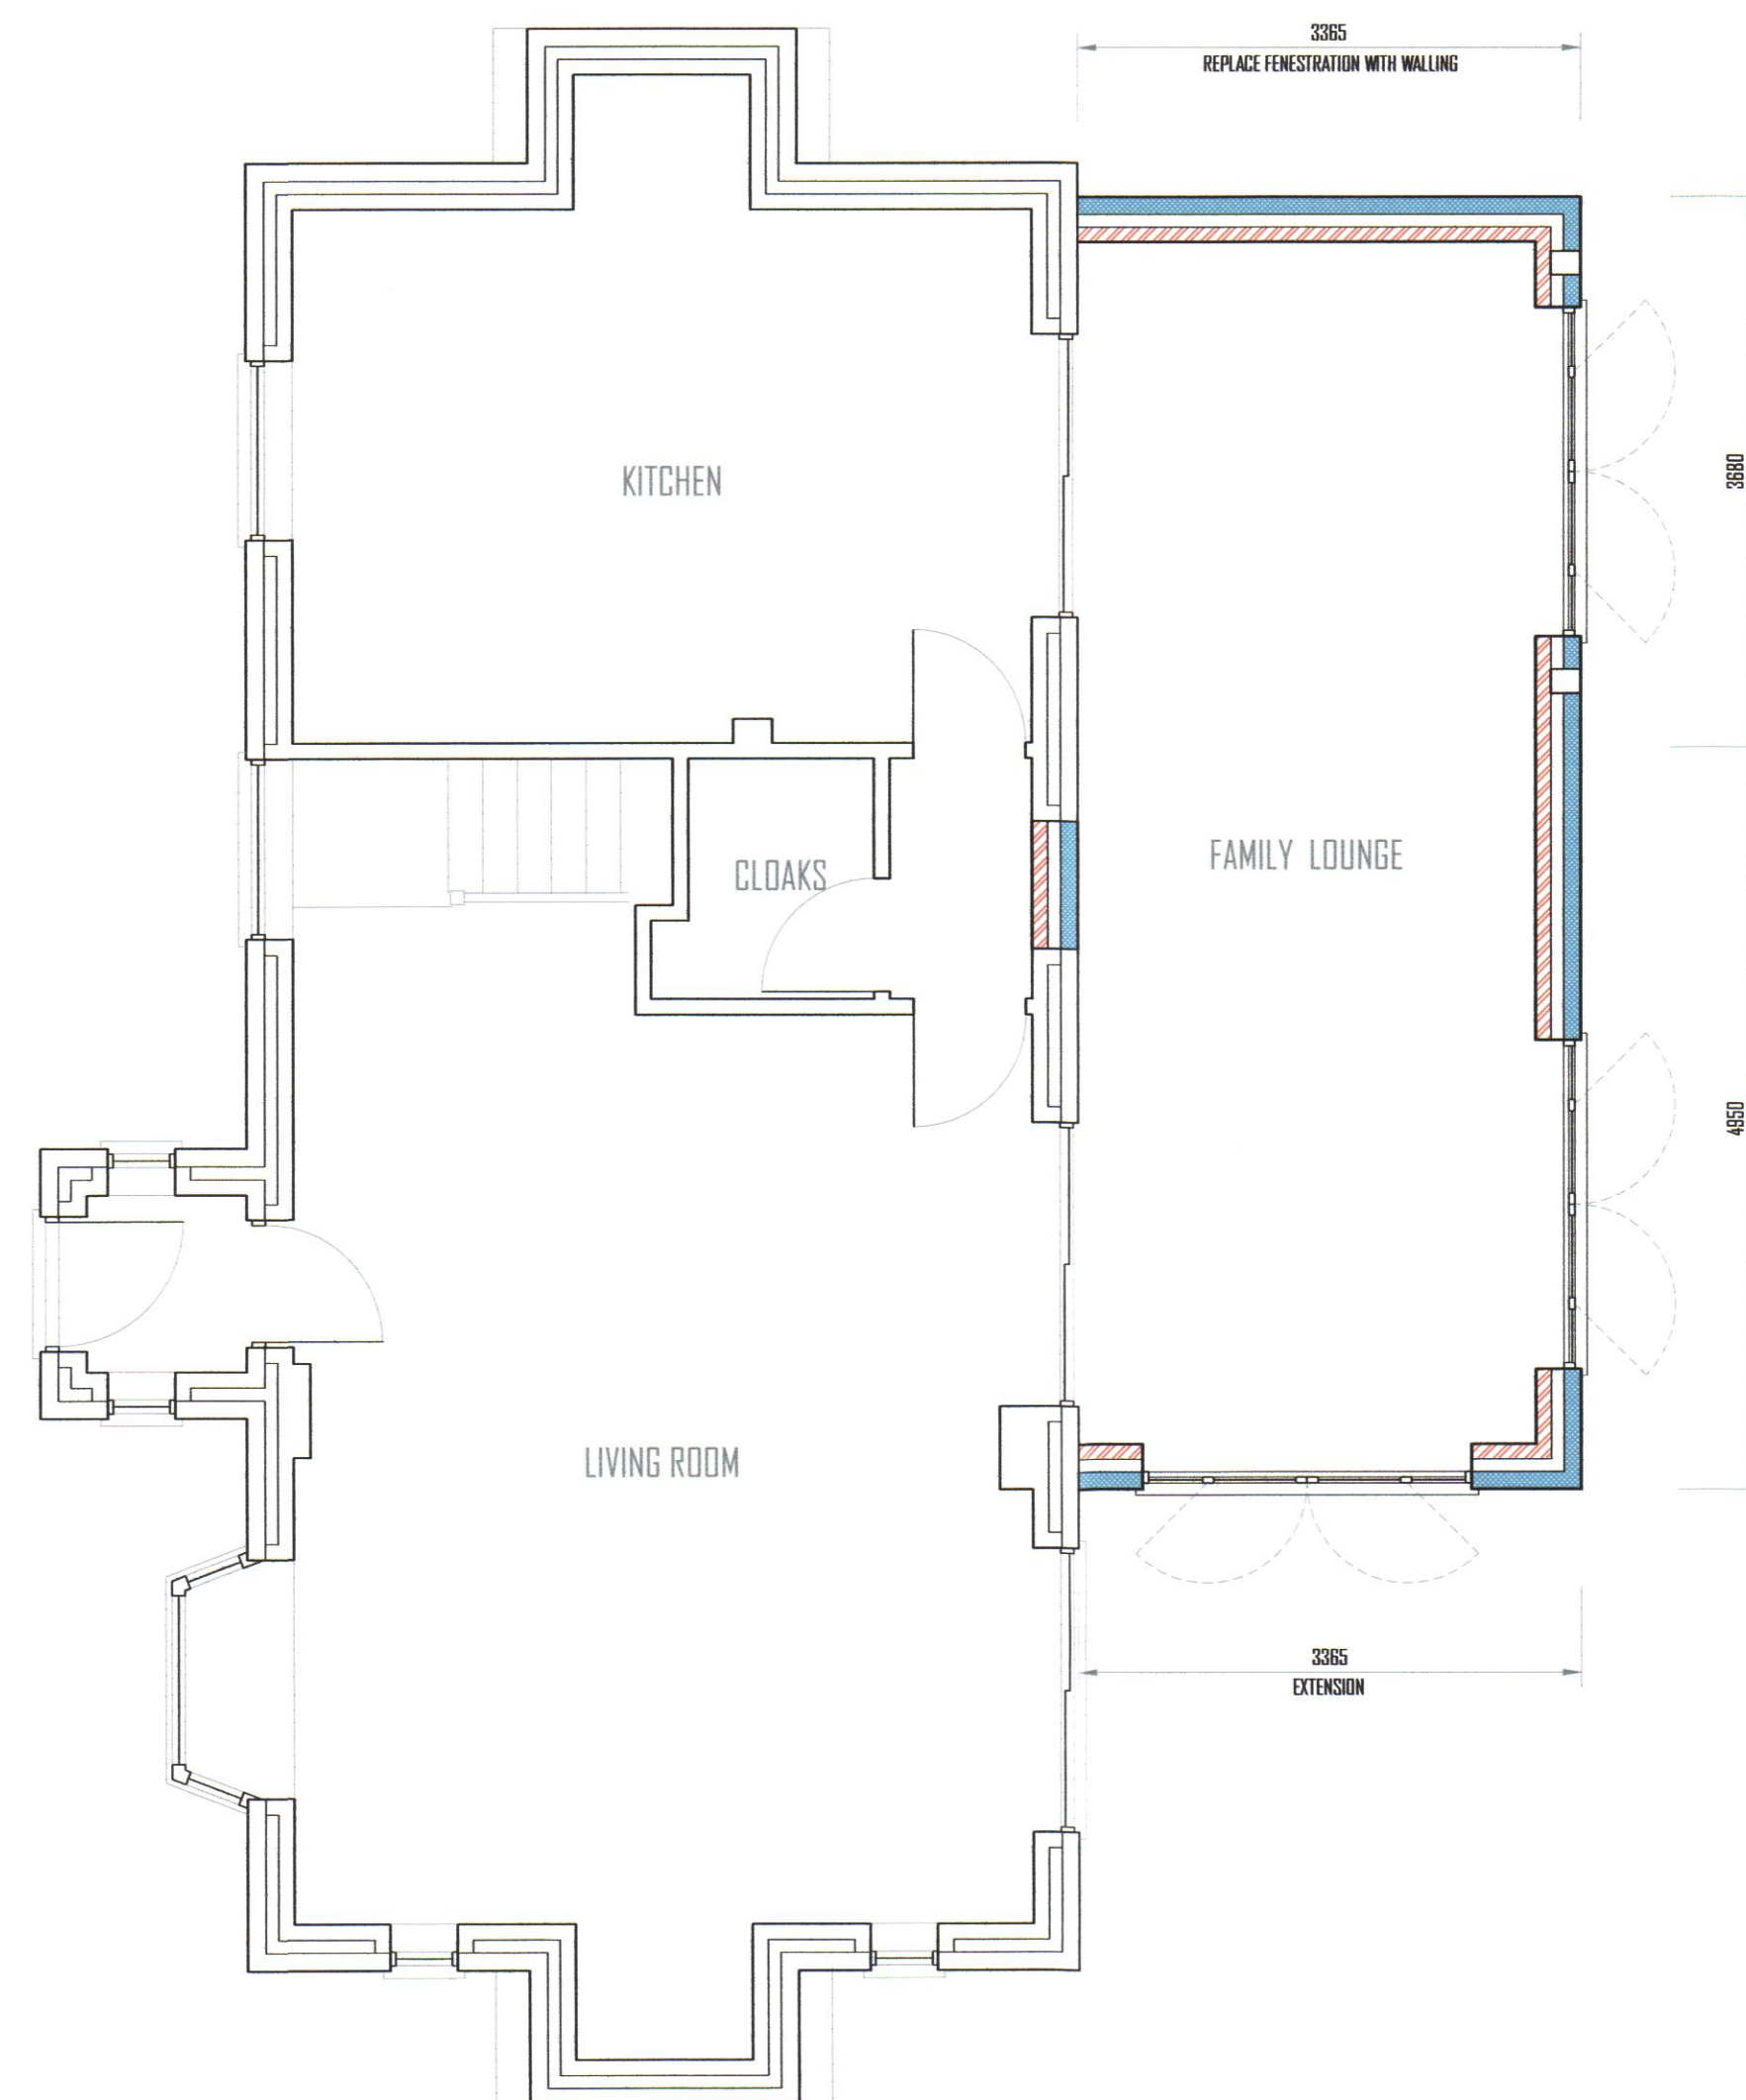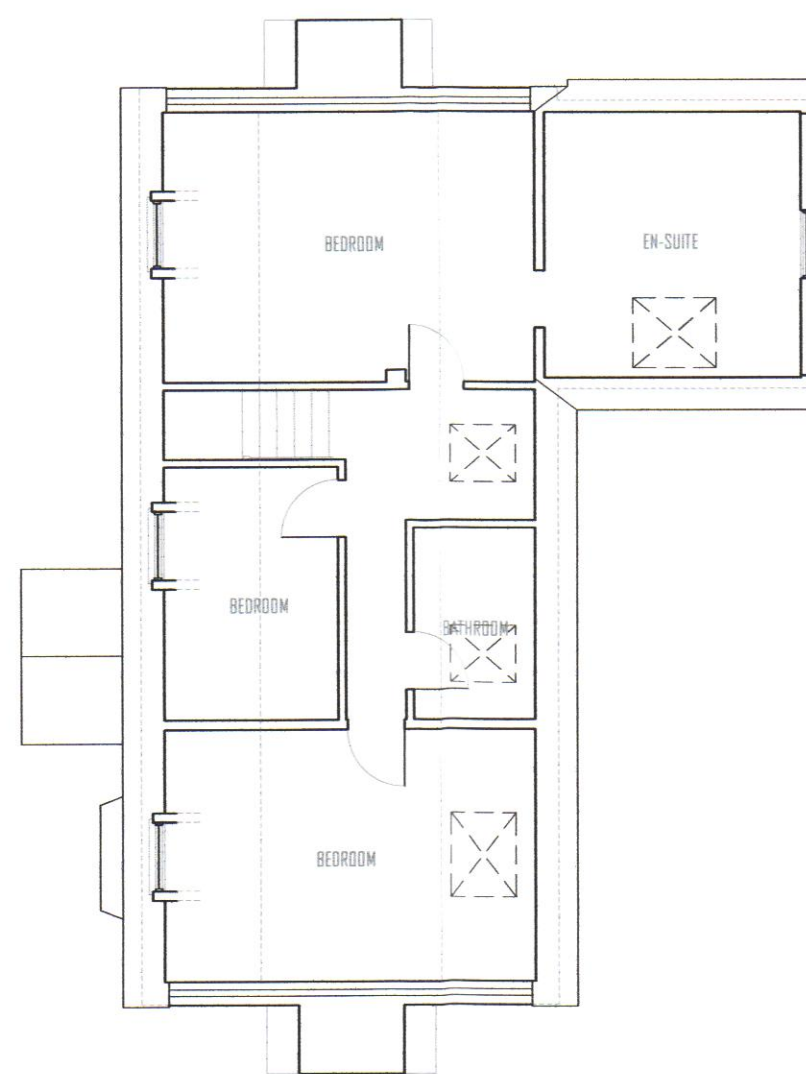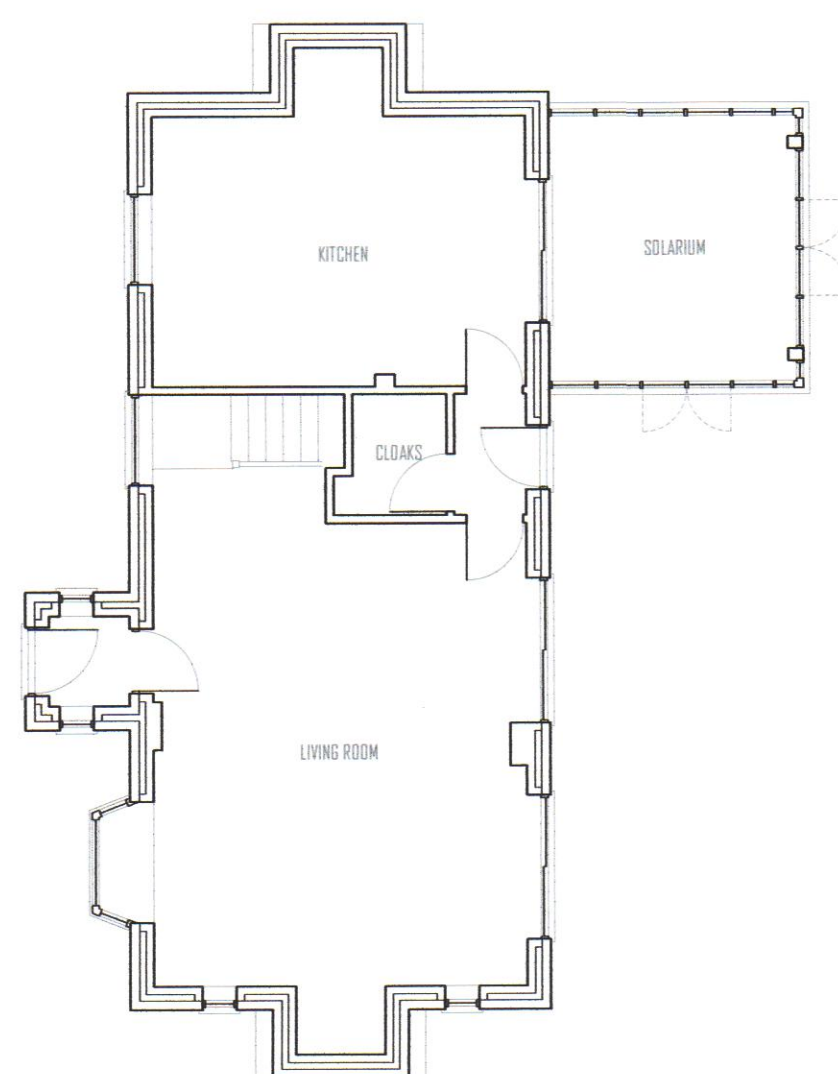

PROPOSED GROUND FLOOR PLAN Scale 1:50

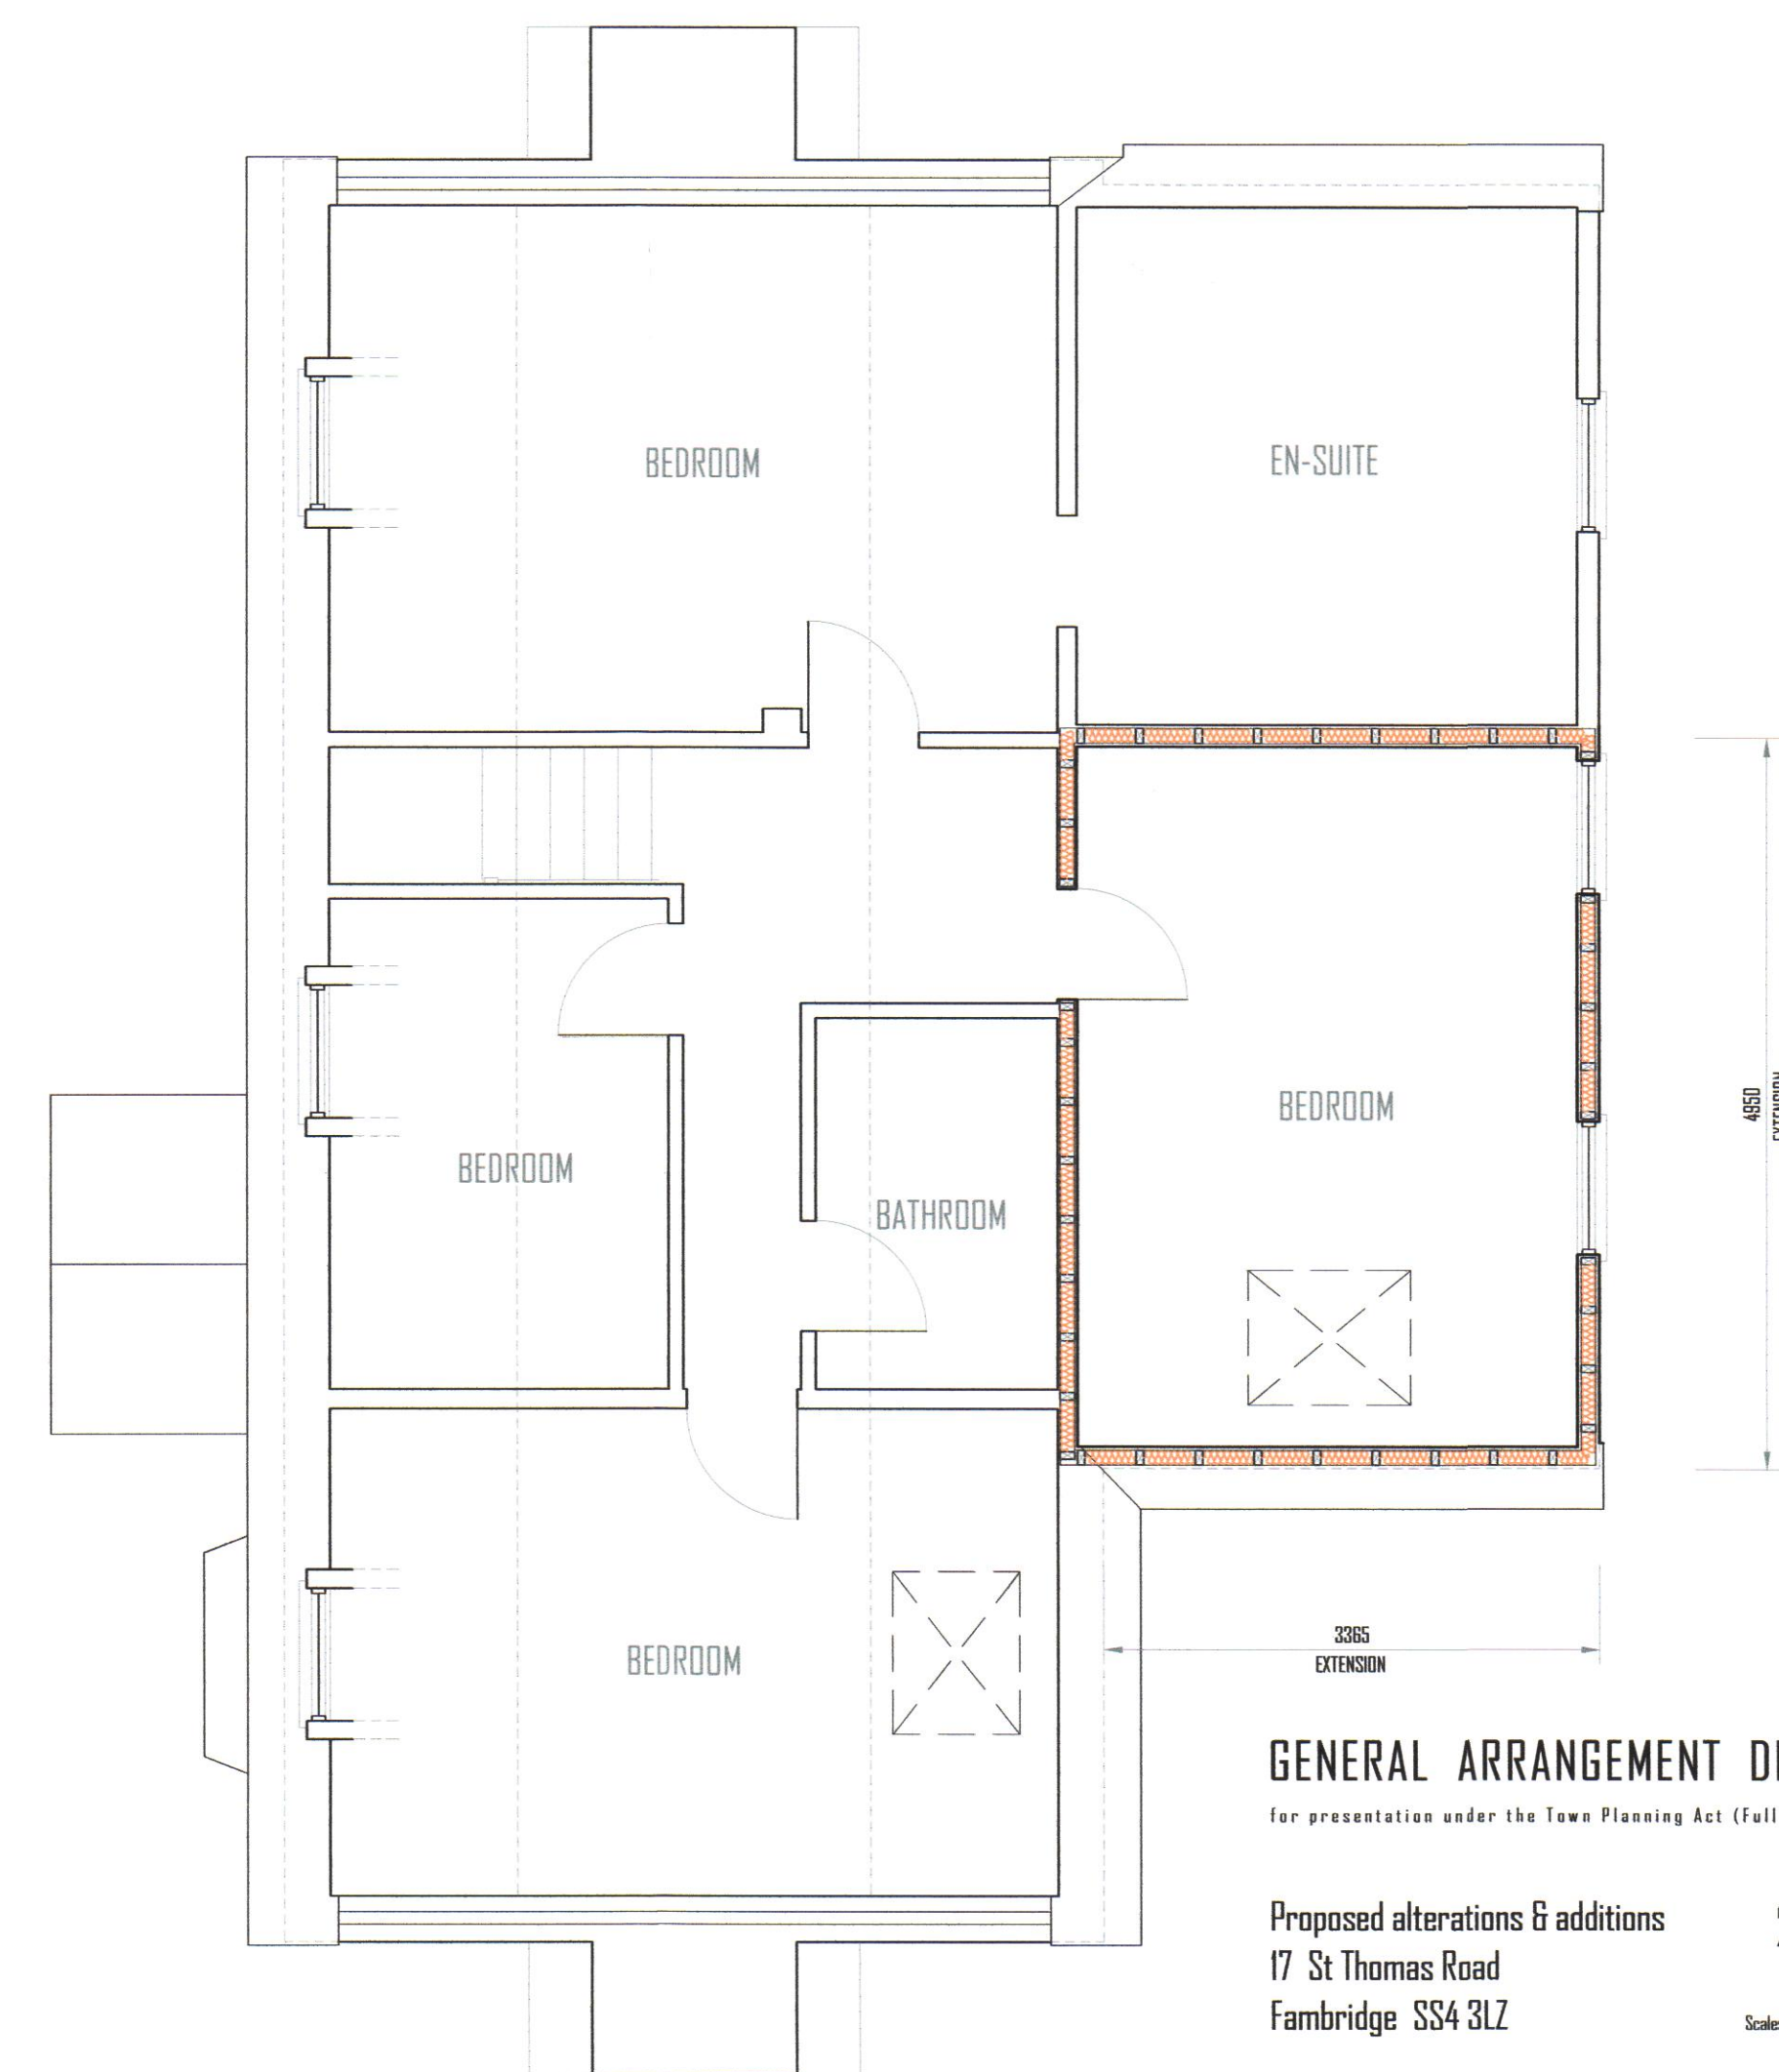

PROPOSED FIRST FLOOR PLAN Scale 1:50



GENERAL ARRANGEMENT DRAWING
for presentation under the Town Planning Act (Full Householder)

Proposed alterations & additions
17 St Thomas Road
Fambridge SS4 3LZ

2799 05
April 2015
Scales as shown when H/A



MARK HIPSEY
92 London Road
Southend on Sea
Essex SSI 1PG
Office: 07702 300 101
Mobile: 07950 833 943
E-mail: mark@markhipsey.co.uk
Website: markhipsey.com

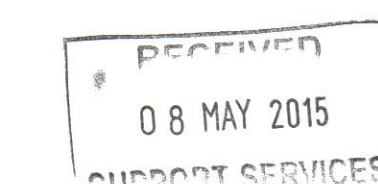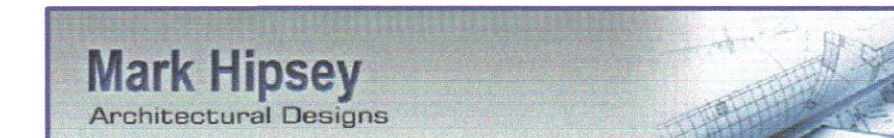

17 St Thomas Road