




Scale 1:100

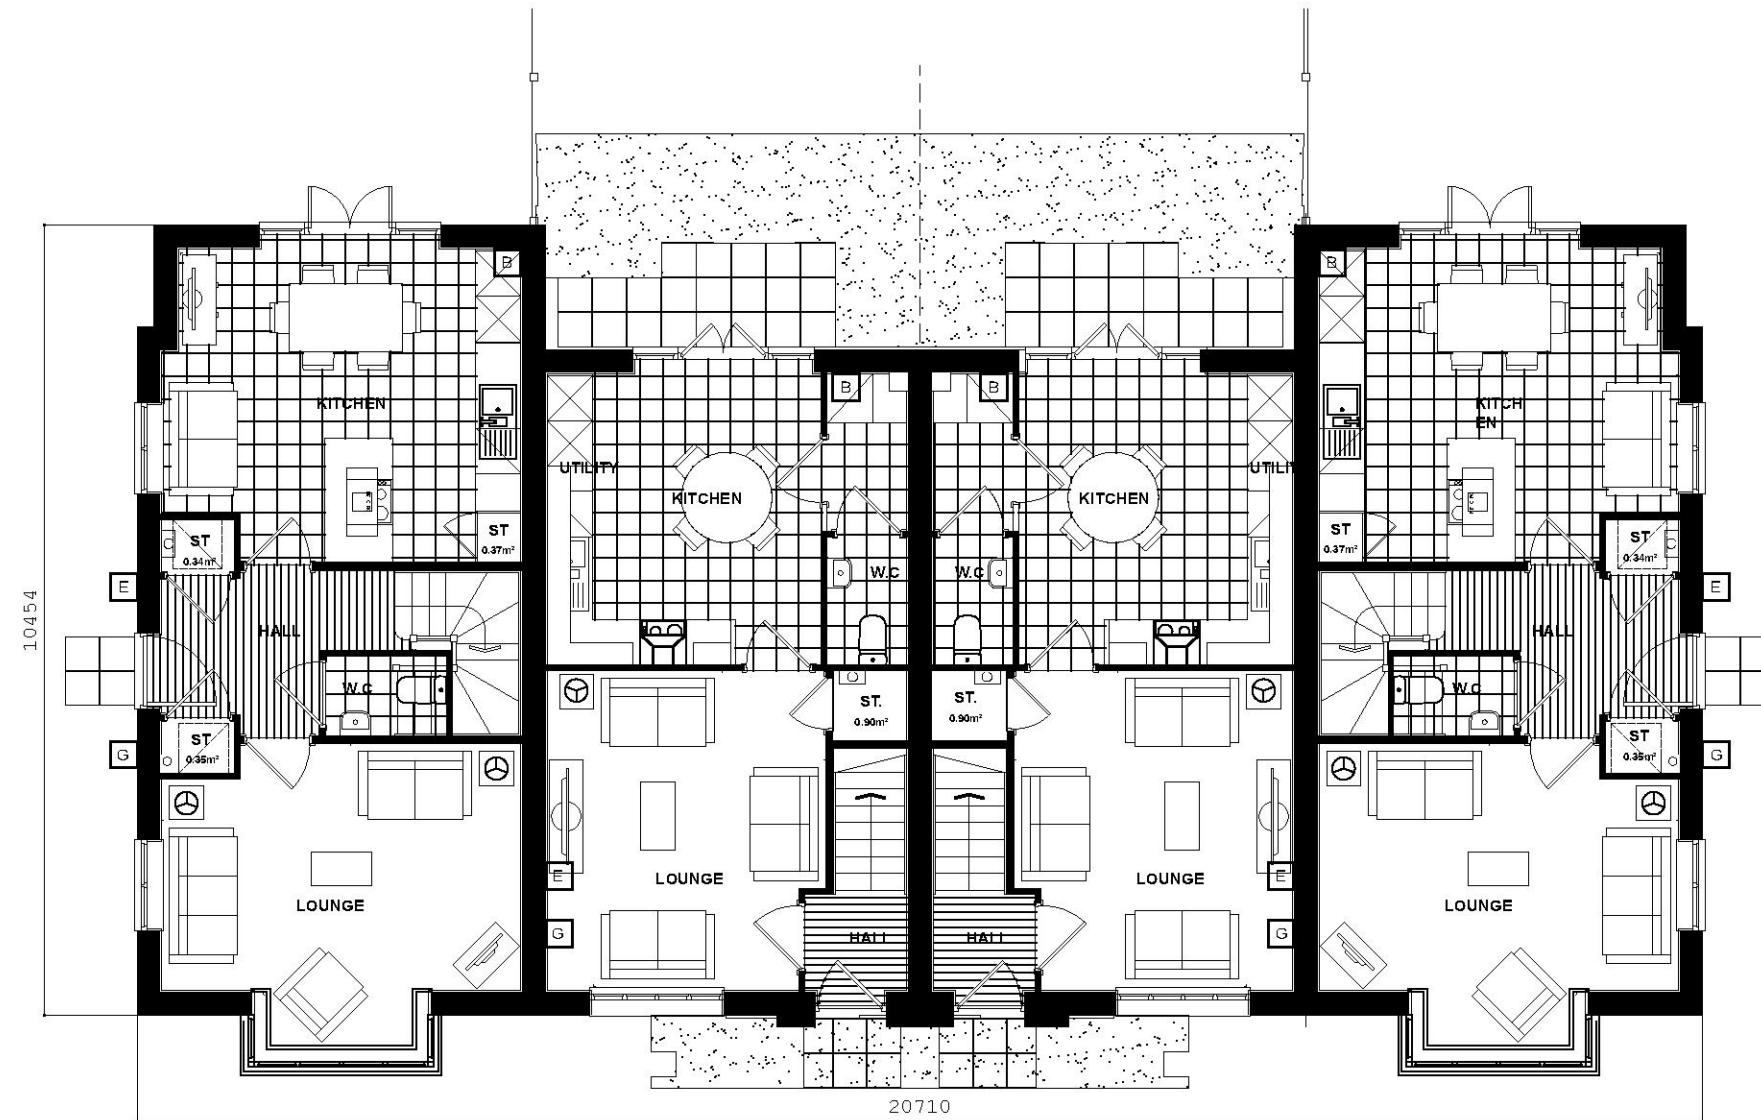

GROUND FLOOR PLAN  
MACAULAY

NSS.383  
MAYNARD

NSS.383-1  
MAYNARD

GROUND FLOOR PLAN  
MACAULAY

**B** BOILER LOCATION **E** ELECTRIC METER LOCATION **GF** GAS FLOOR BOX LOCATION **C** CONSUMER UNIT LOCATION

PEGASUS DRAWING NUMBER:  
P18 2109 70\_36

**NOTES:**

DRAWING BASED ON LINEWORK  
PROVIDED BY BLOOR HOMES.  
(DRAWING NO: NSS.383.PL 01 &  
NSS.BSP420.PL 01)

REFER TO MATERIALS LAYOUT  
FOR INDIVIDUAL PLOT  
MATERIALS INCLUDING DOOR  
COLOURS.(DRAWING NO:  
P18 2109 62 03)

**PLOT NUMBERS**  
AS: 399 402  
HANDED:

# Macauley Maynard FLOORPLANS

DATE: APR 2019  
SCALE: 1:100 @ A3

DRAWN: GW  
CHECKED: GPM

REV:

87.30 / 85.35m<sup>2</sup>  
940 / 919 ft<sup>2</sup>

